

KEYED SHEET NOTES	
1	MAINTAIN EXISTING BROADCAST TIELINE PANEL.


MN Legislature TV System Acquisition




Legislative Coordinating Commission
 MINNESOTA CAPITOL BUILDING
 75 REV DR. MARTIN LUTHER KING BLVD.
 ST. PAUL, MN 55155
 0713923

FINEPOINT TECH

416 Gateway Blvd
 Burnsville MN, 55337
 612.254.7462
 finepoint.tech


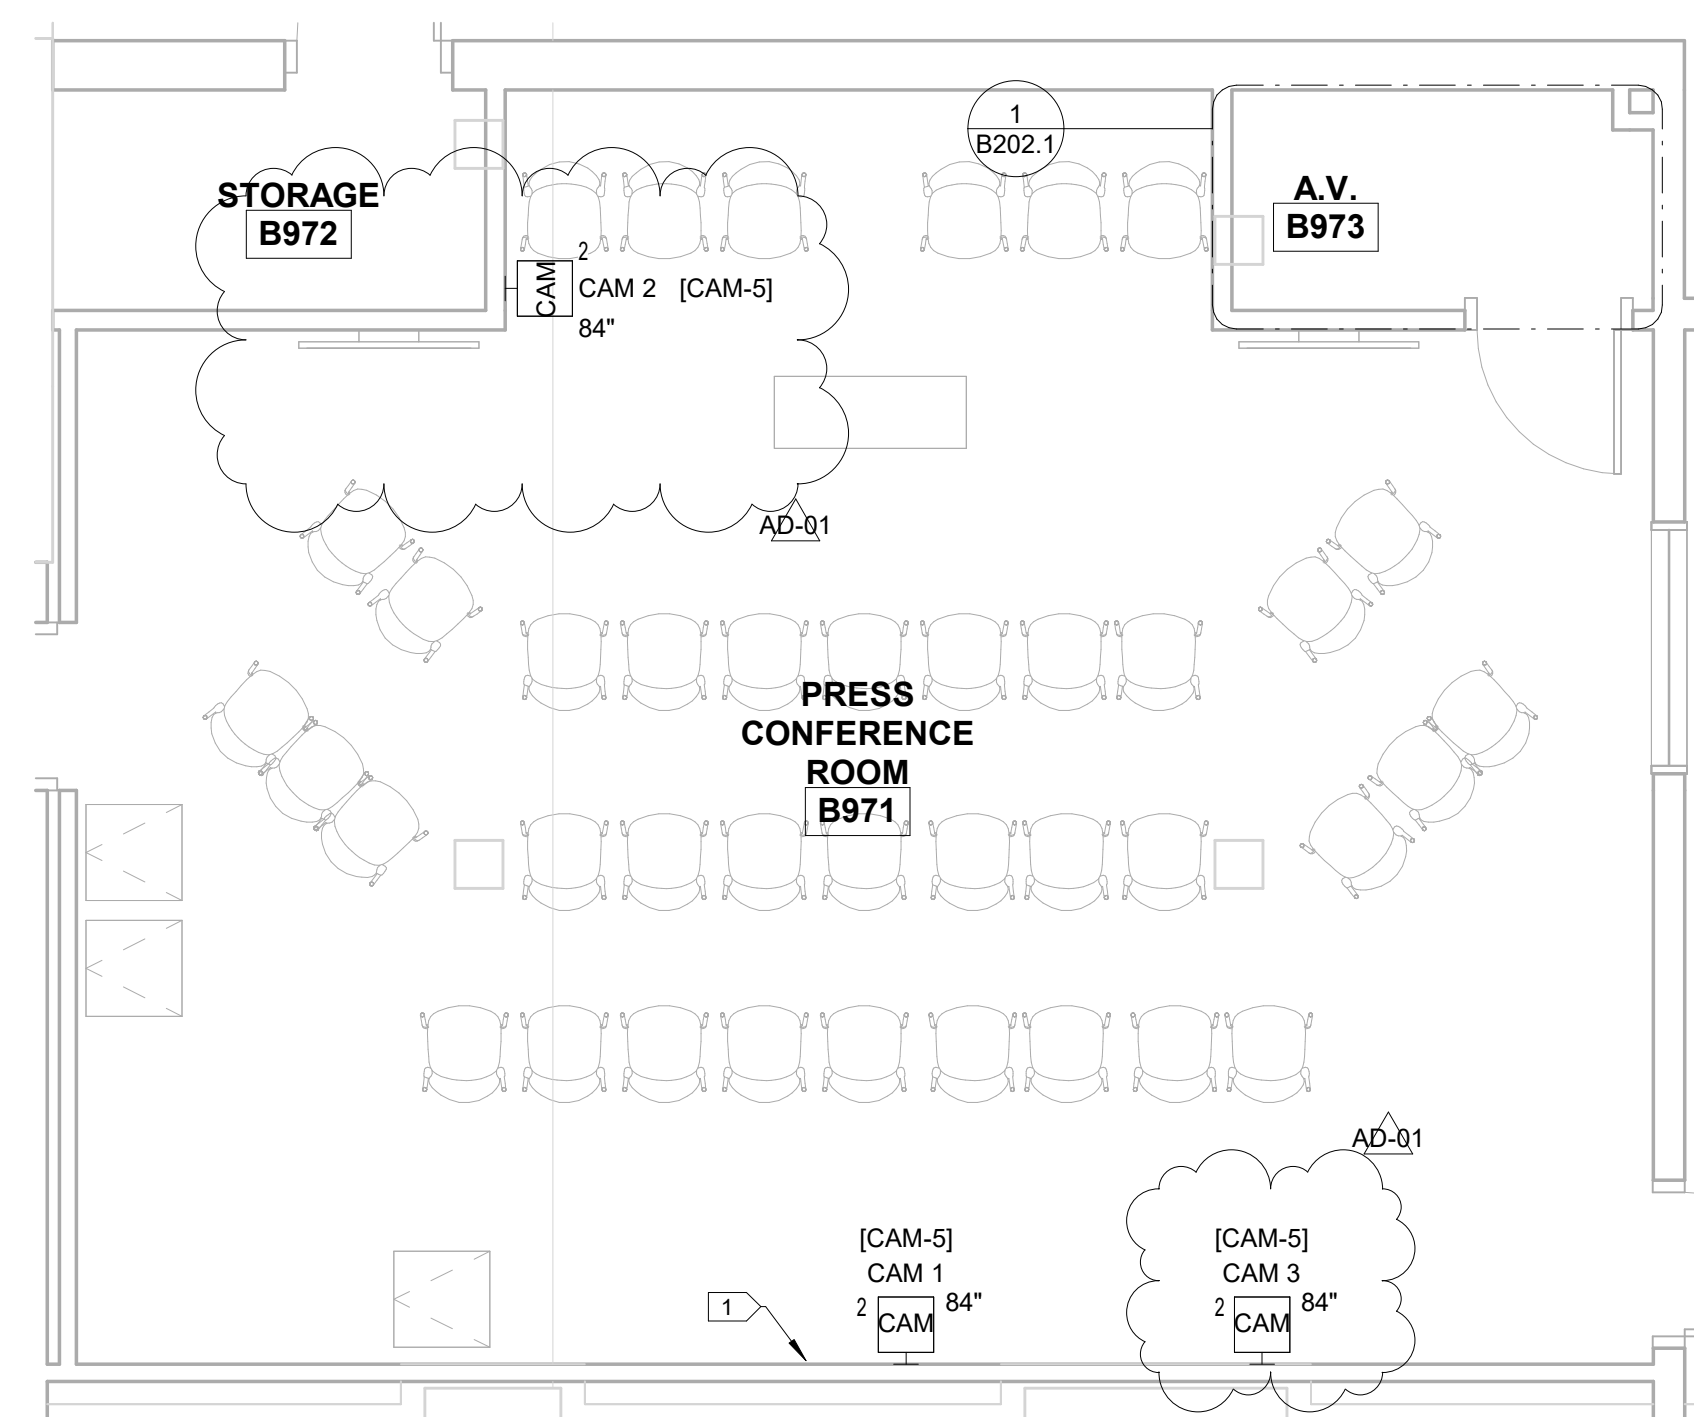


1 PRESS CONFERENCE ROOM-B971 ENLARGED FLOOR PLAN
 SCALE: 1/4" = 1'-0"

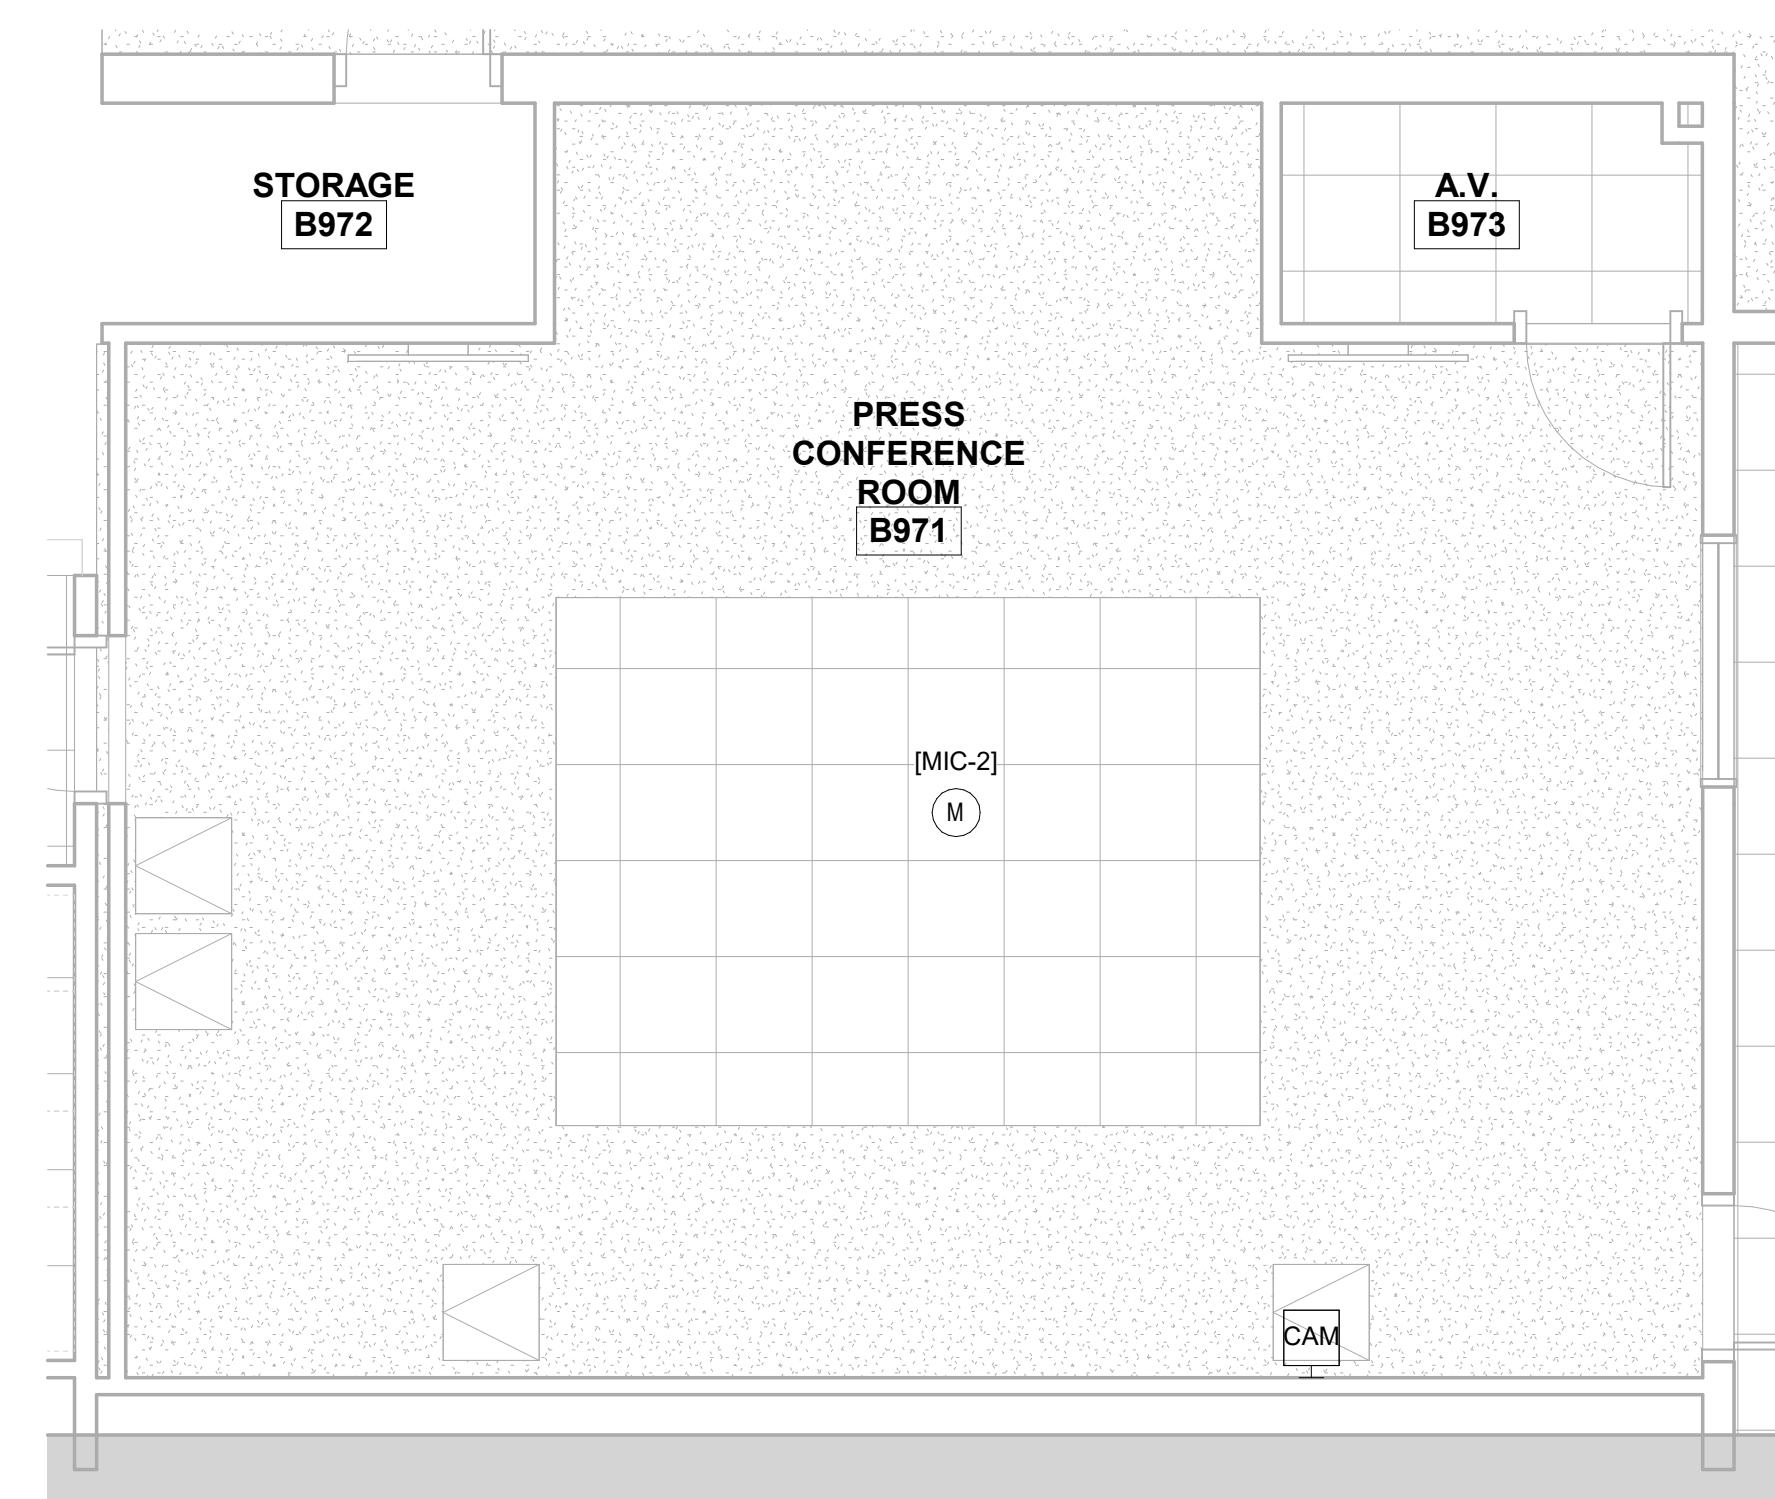

2 PRESS CONFERENCE ROOM-B971 ENLARGED RCP
 SCALE: 1/4" = 1'-0"

Issued For	
Item	Date
Issued For Bid	05/20/2024
AD-01	06/20/2024

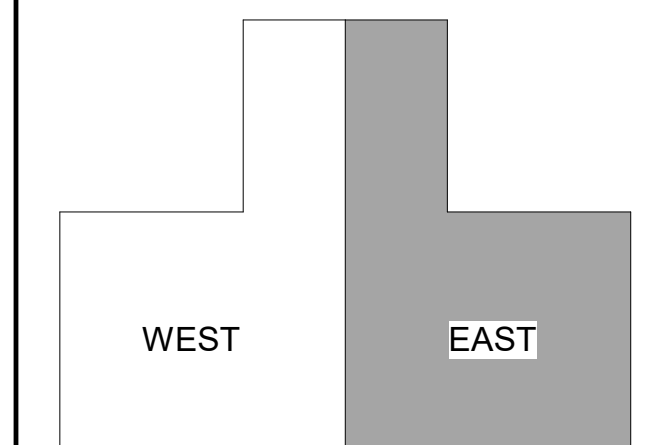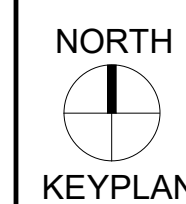

Sheet Title
ENLARGED PRESS CONFERENCE-B971

Sheet No.
B201.1

Drawn By: DS/SR/TD