

KEYED SHEET NOTES	
Key Value	Keynote Text
1	MAINTAIN OFOI EXISTING CAMERA.
2	BRACE AND/OR PROVIDE VIBRATION DAMPENING FOR CAMERA CEILING POLE MOUNT.

MN Legislature TV System Acquisition PM



Legislative Coordinating Commission

MINNESOTA SENATE BUILDING
95 University Ave W,
St Paul, MN 55103

0713923

FINEPOINT TECH

416 Gateway Blvd
Burnsville MN, 55337
612.254.7462
finepoint.tech

Issued For	
Item	Date
Issued For Bid	05/20/2024
AD-01	06/20/2024


Sheet Title

HR-1200 ENLARGED FLOOR PLAN


Sheet No.

B201.3

Drawn By: DS/SR/TD

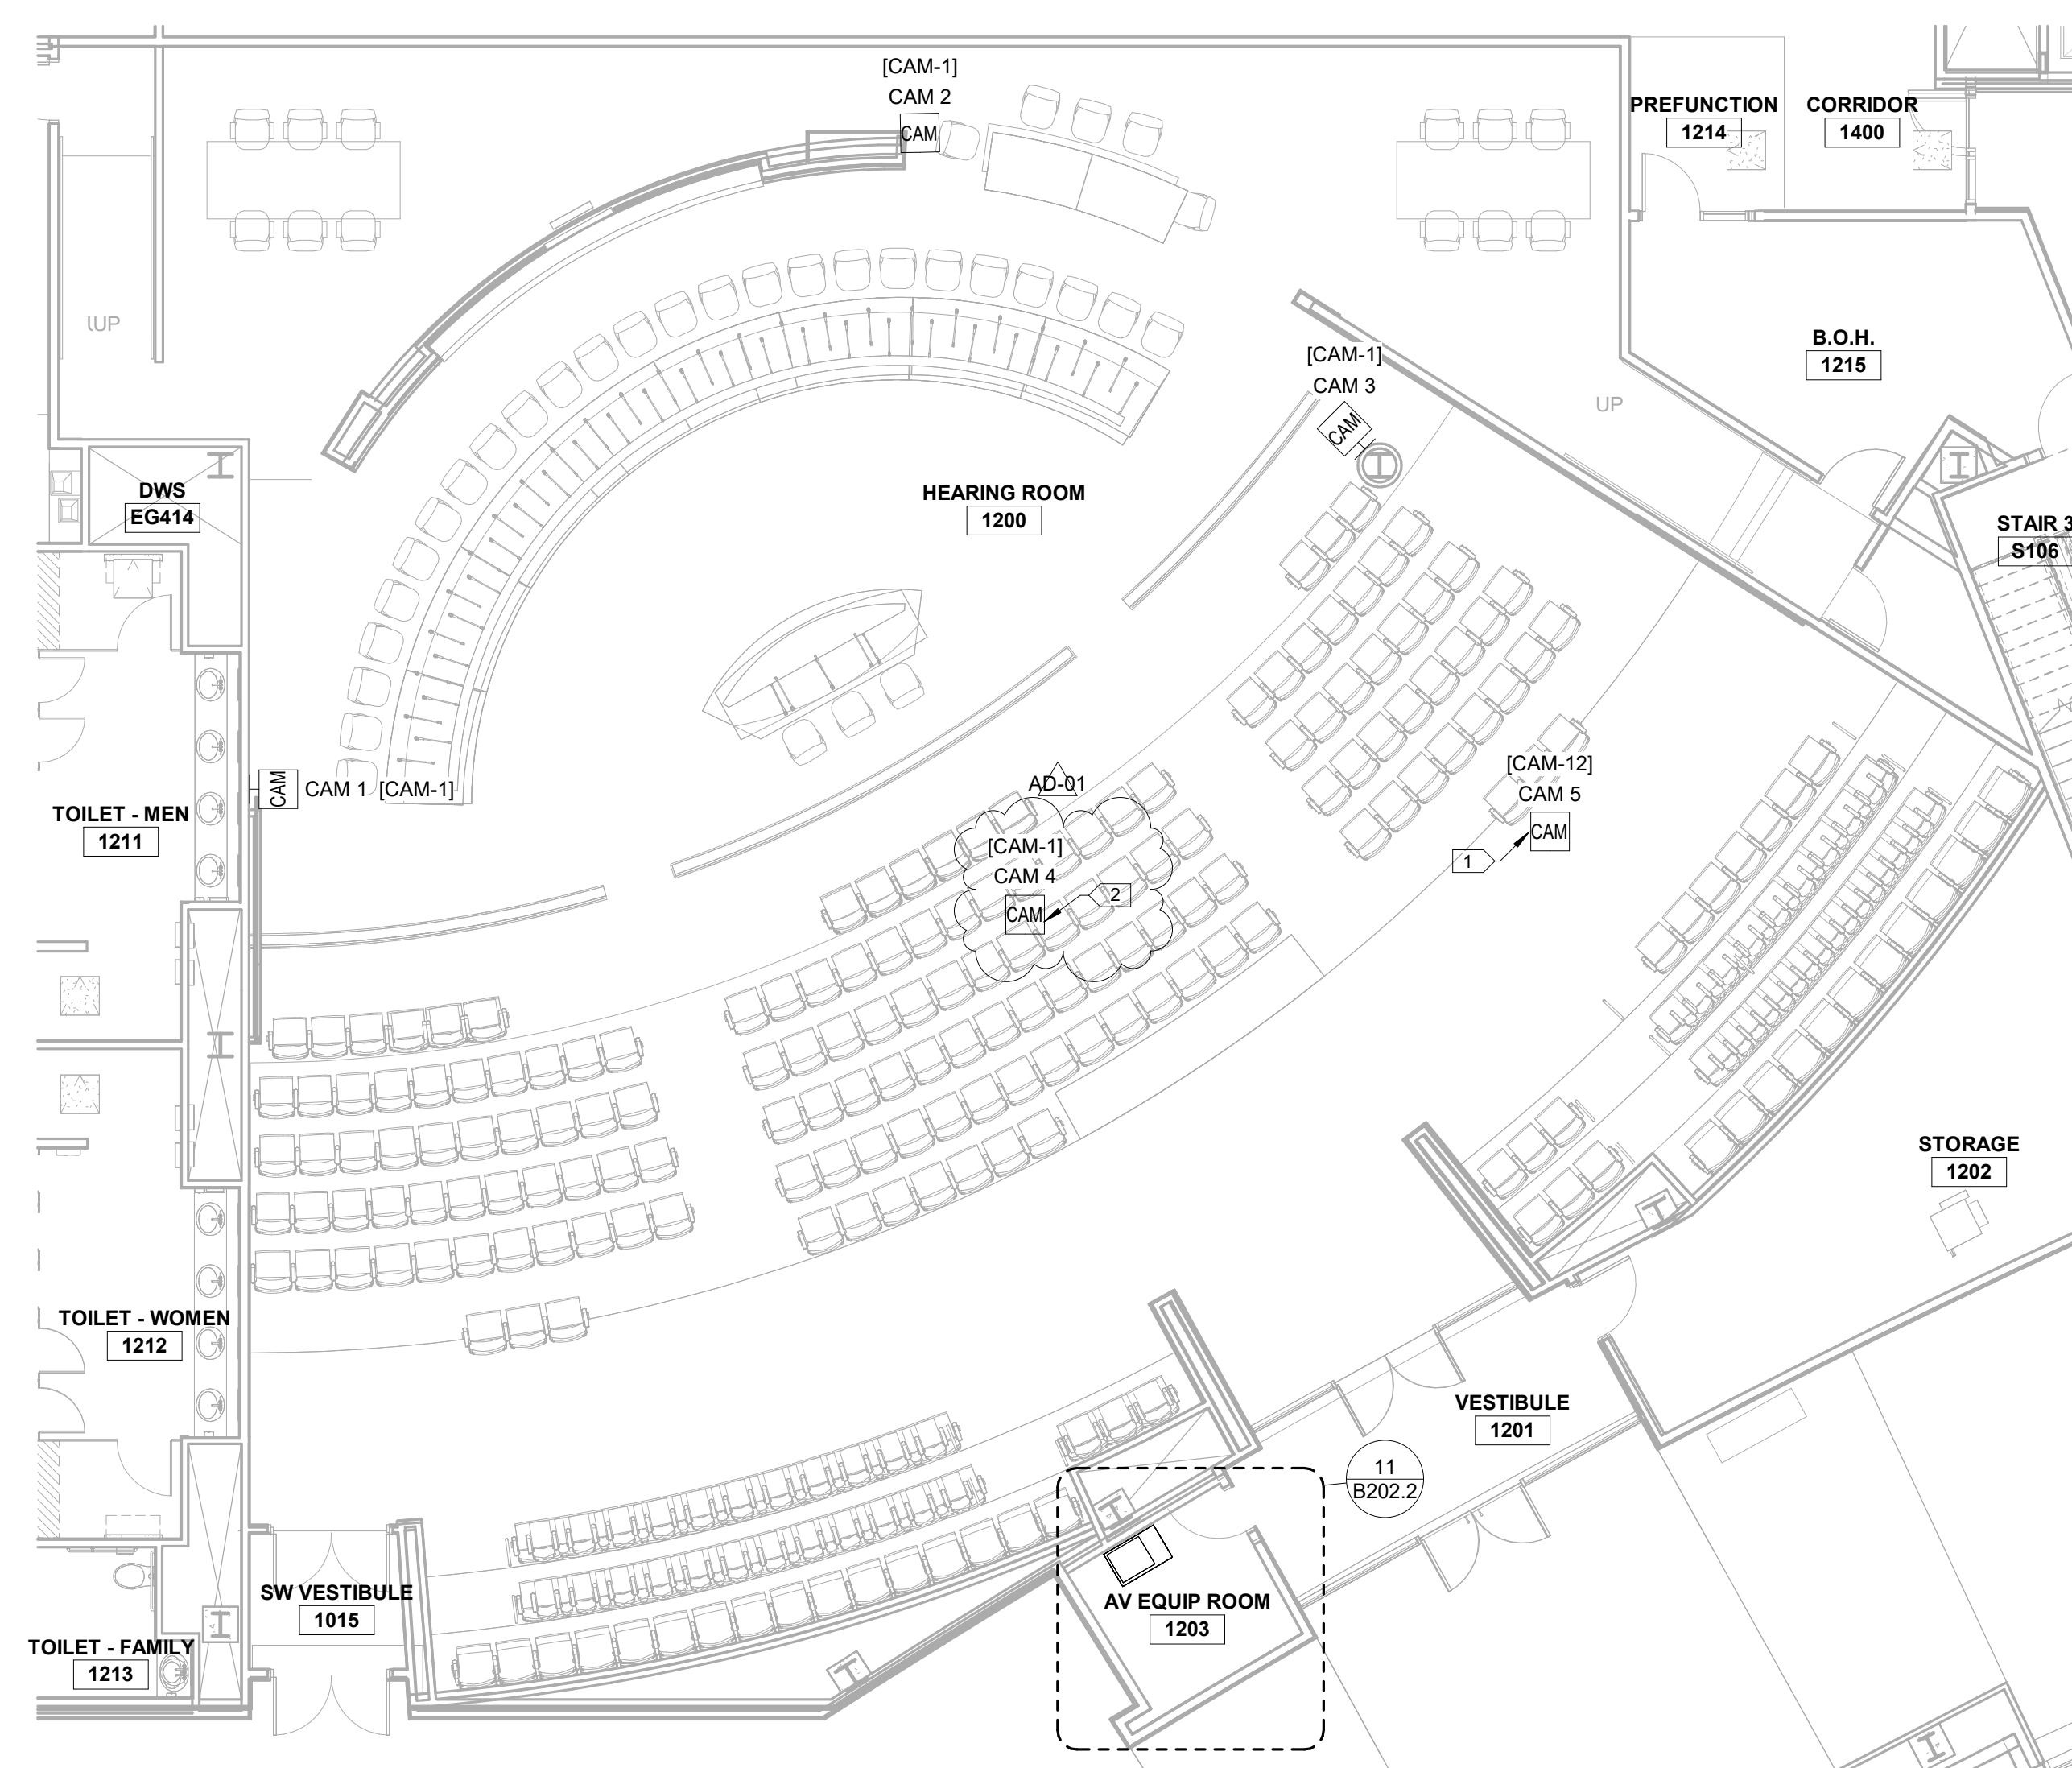

1 HR-1200 ENLARGED FLOOR PLAN
SCALE: 1/8" = 1'-0"

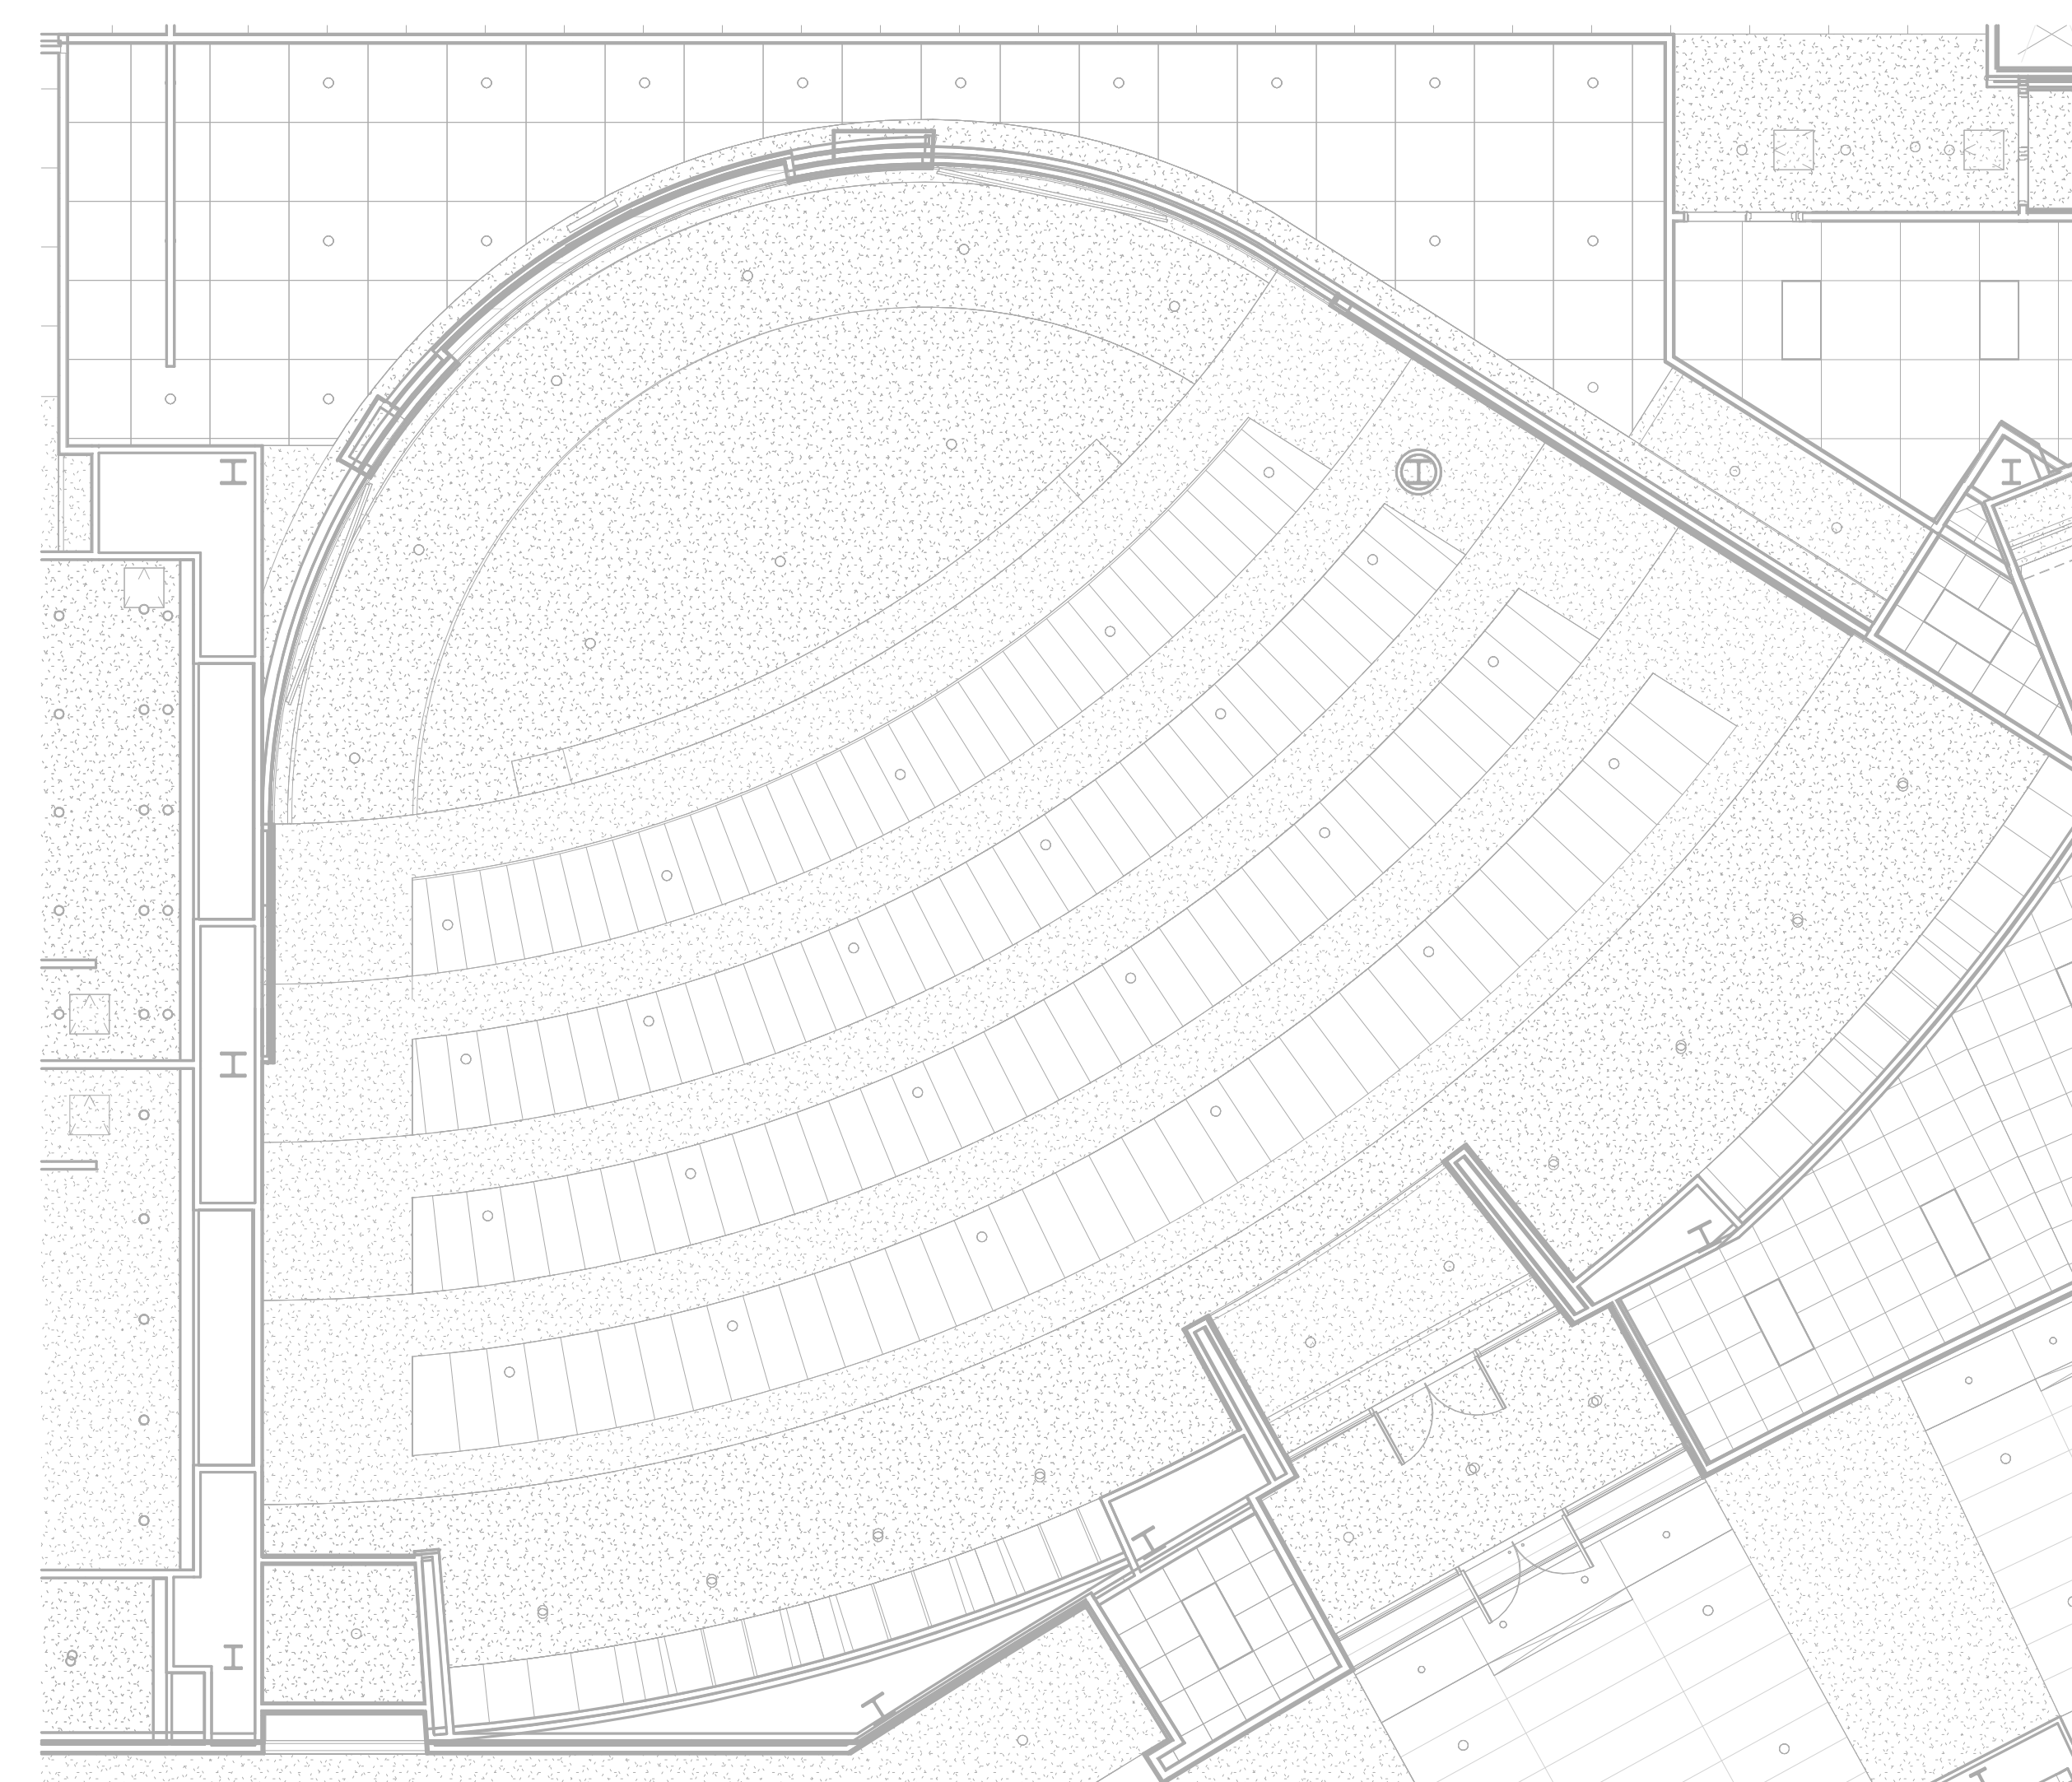

2 HR-1200 ENLARGED RCP
SCALE: 1/8" = 1'-0"